




SITE PLAN

SCALE: 1" = 100'

EXISTING POWERLINE
DROP FEED TO
RELEASE PONDS

WDFW RELEASE PONDS SITE
(PROPERTY BOUNDARY)

POWER POLE

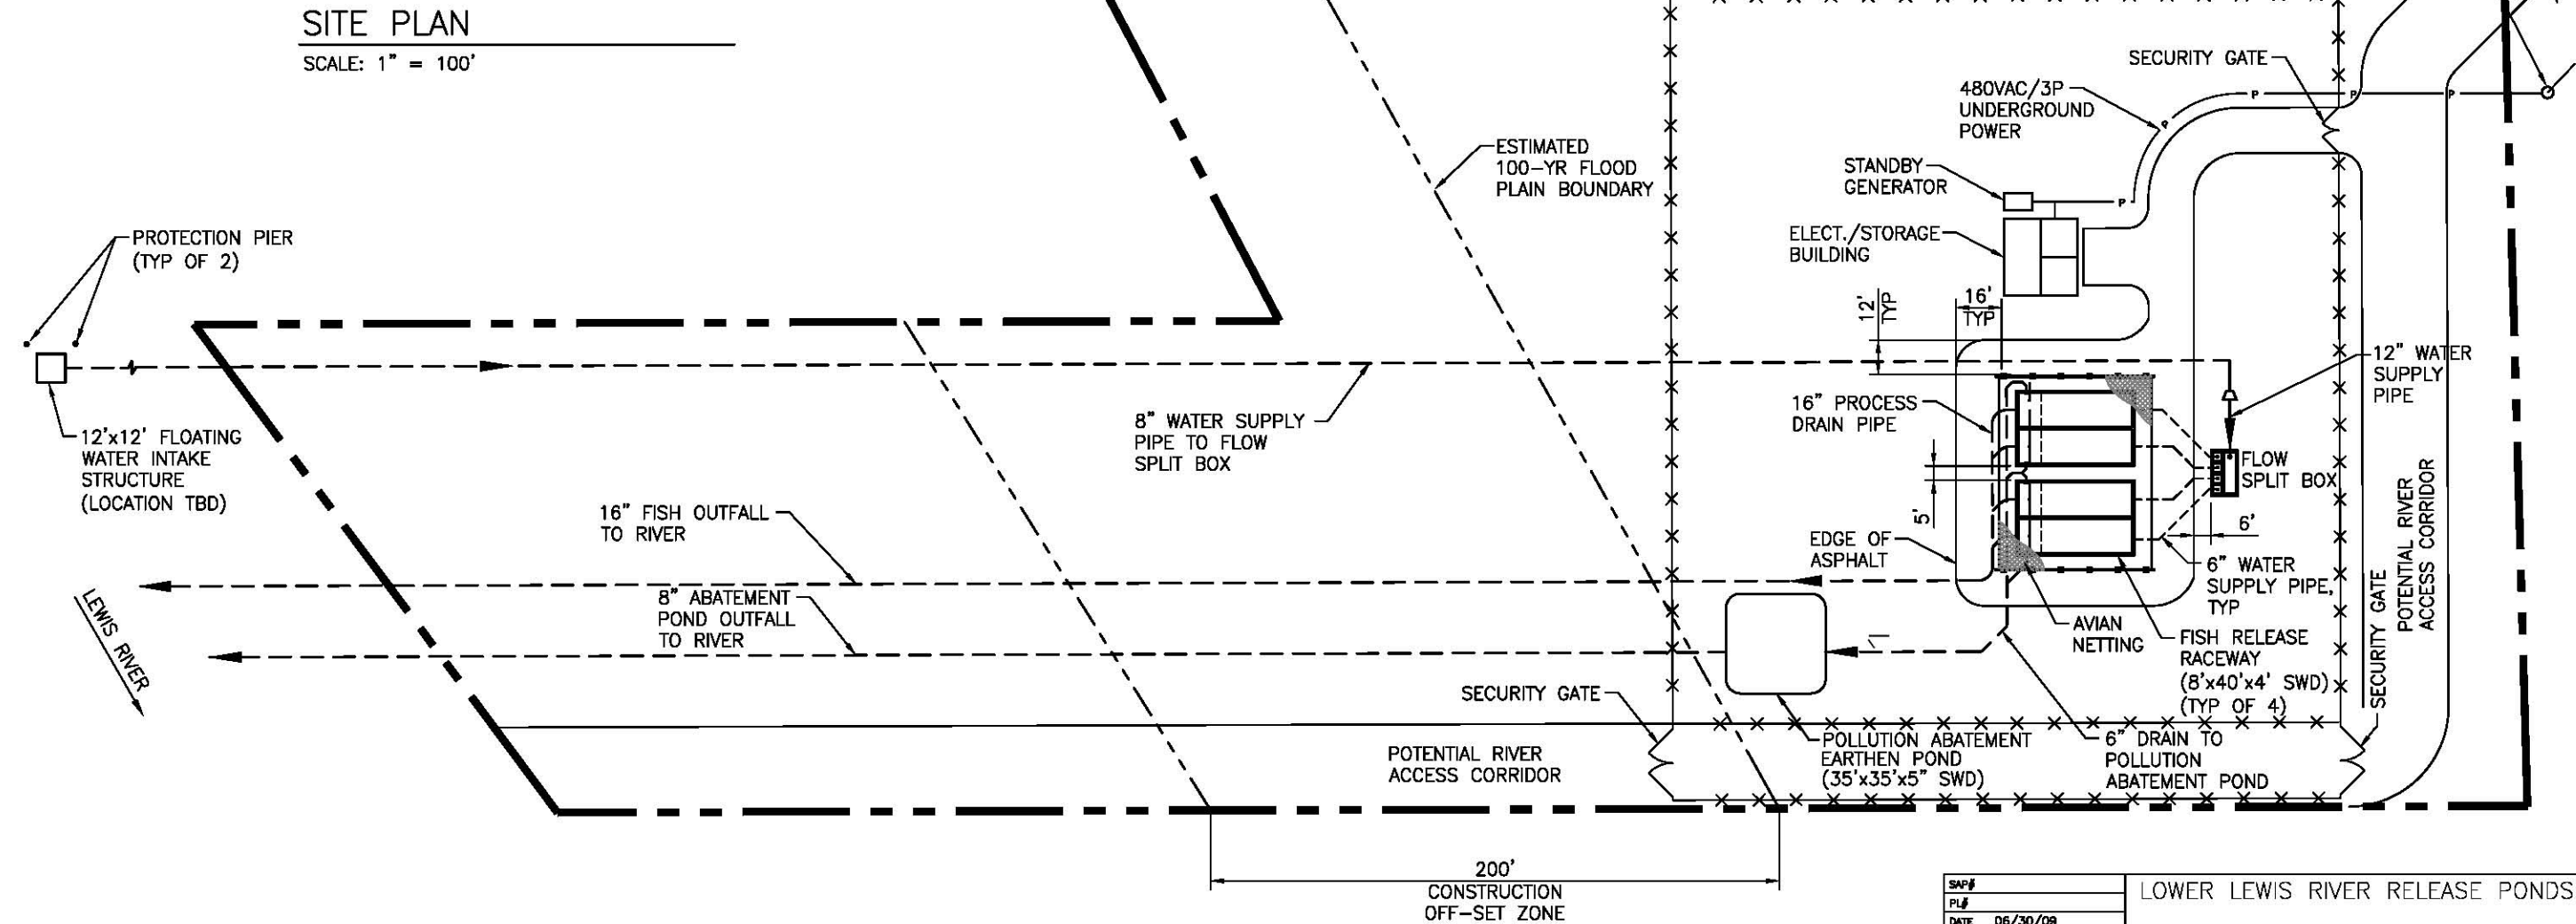

CONCEPTUAL PLAN

SCALE: 1" = 30'


WARNING

0 1/2 1
IF THIS BAR DOES NOT MEASURE 1" THEN DRAWING IS NOT TO SCALE.


SAP#		LOWER LEWIS RIVER RELEASE PONDS	
PL#		WDFW SITE CONCEPTUAL PLAN	
DATE	06/30/09	DES	-
ENGL/MOCHAMBI	DES	CH	-
DR	-	CH	-
APPROVAL			
PACIFIC CORP ENERGY		HYDRO	
SCALE: AS NOTED	SHEET	FIG 1	REV. 1

NO.	DATE	REVISION	BY	CHK	APP	DRAWING No.	REFERENCE DRAWINGS

PLT SCALE: 1" = 100'

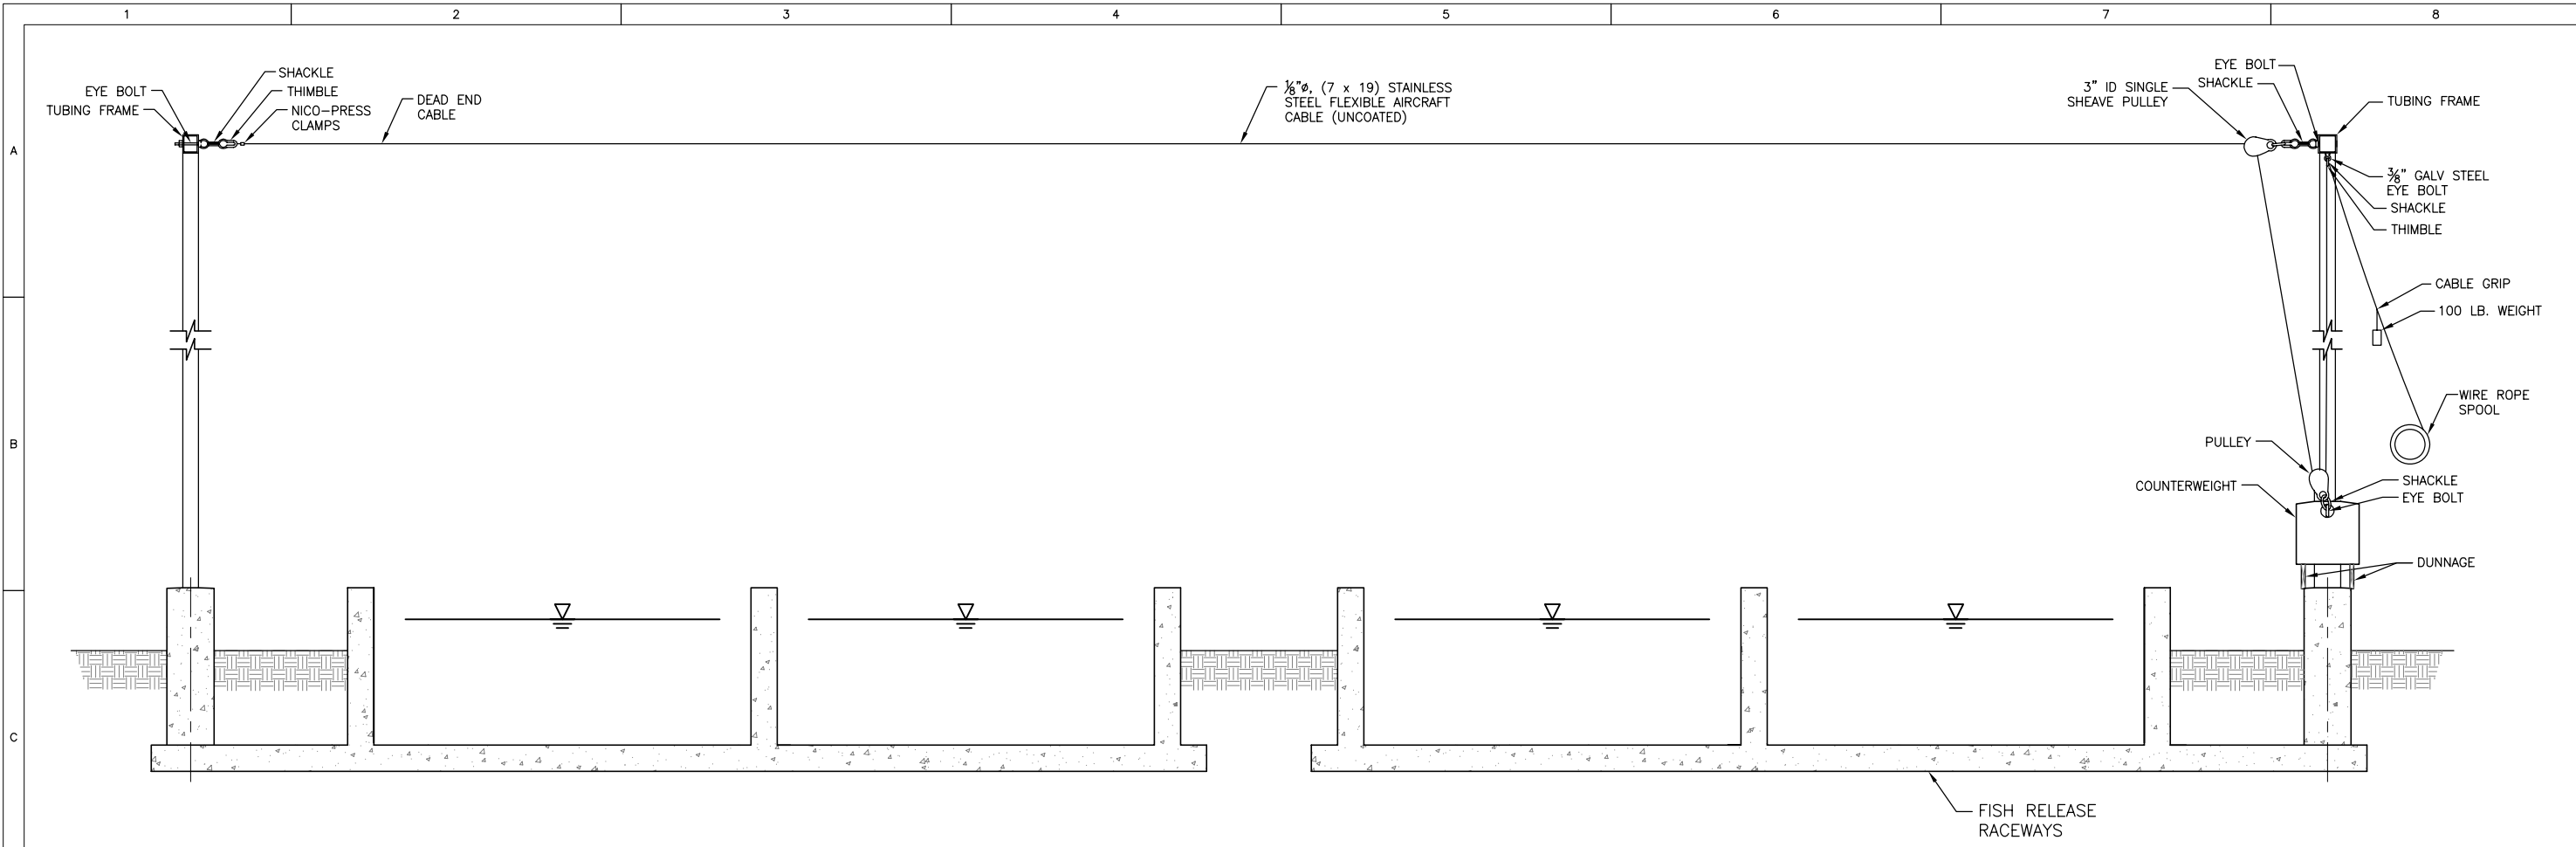

AVIAN NETTING – SECTION
SCALE: 3/8" = 1'-0"

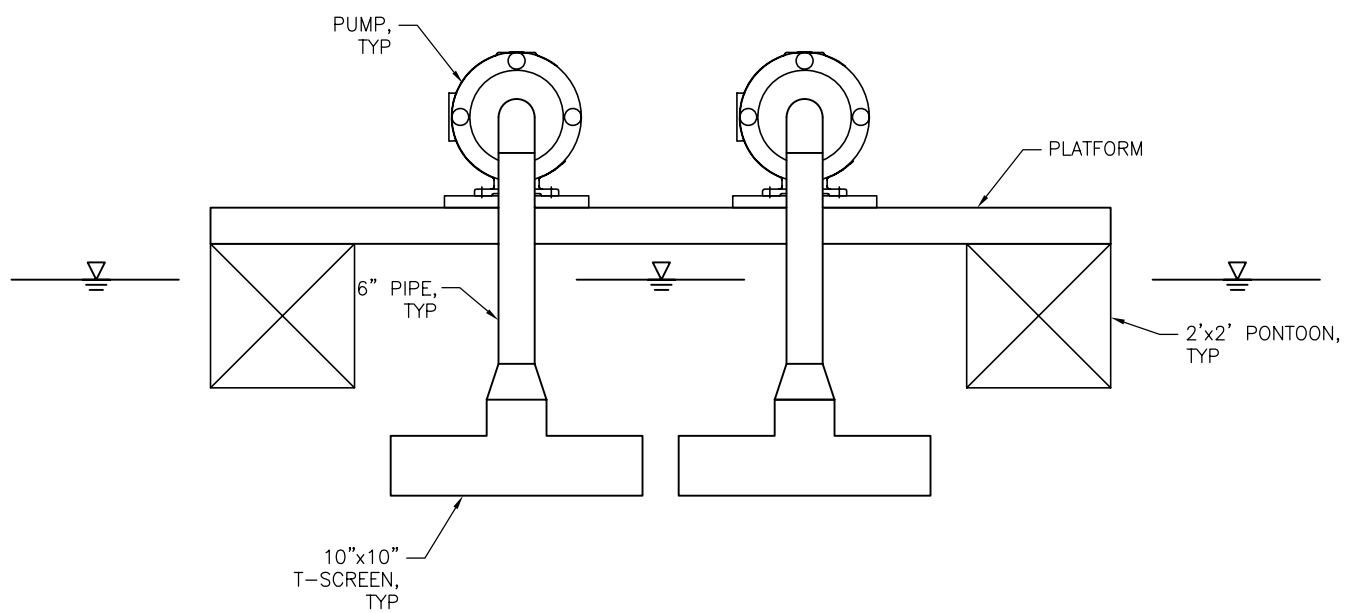

PUMP STATION INTAKE T-SCREEN – SECTION
SCALE: 3/4" = 1'-0"

WARNING
1/2 1
IF THIS BAR DOES NOT MEASURE 1" THEN DRAWING IS NOT TO SCALE.

SAP#	LOWER LEWIS RIVER RELEASE PONDS		
PL#			
DATE	06/30/09		
ENGM	MOUGHAMIAN	DES	-
DR	-	CH	-
APPROVAL			
PACIFICORP ENERGY		HYDRO	
SCALE:	AS NOTED	SHEET	FIG 2
REV.	1		

REFERENCE DRAWINGS							
DRAWING No.							
REFERENCE DRAWINGS							
DRAWING No.							
CHK APP							
BY							
REVISION							
DATE							
No.							
CHK APP							
BY							
REVISION							
DATE							
No.							

PLOT SCALE: 1" = 100'